

PROPOSED PLAN
FOR P.N.B. BANK AT
BASSI PATHANA .


WORKING DRAWING

CCTV LEGEND

S.No.	SYMBOL	DESCRIPTION
01.		LOOPING
02.		CCTV

NOTE:-

IT IS WITH TENTATIVE ROUTING IN THE FALSE CEILING
& CONNECTED WITH POINTS FROM CEILING TO CCTV'S

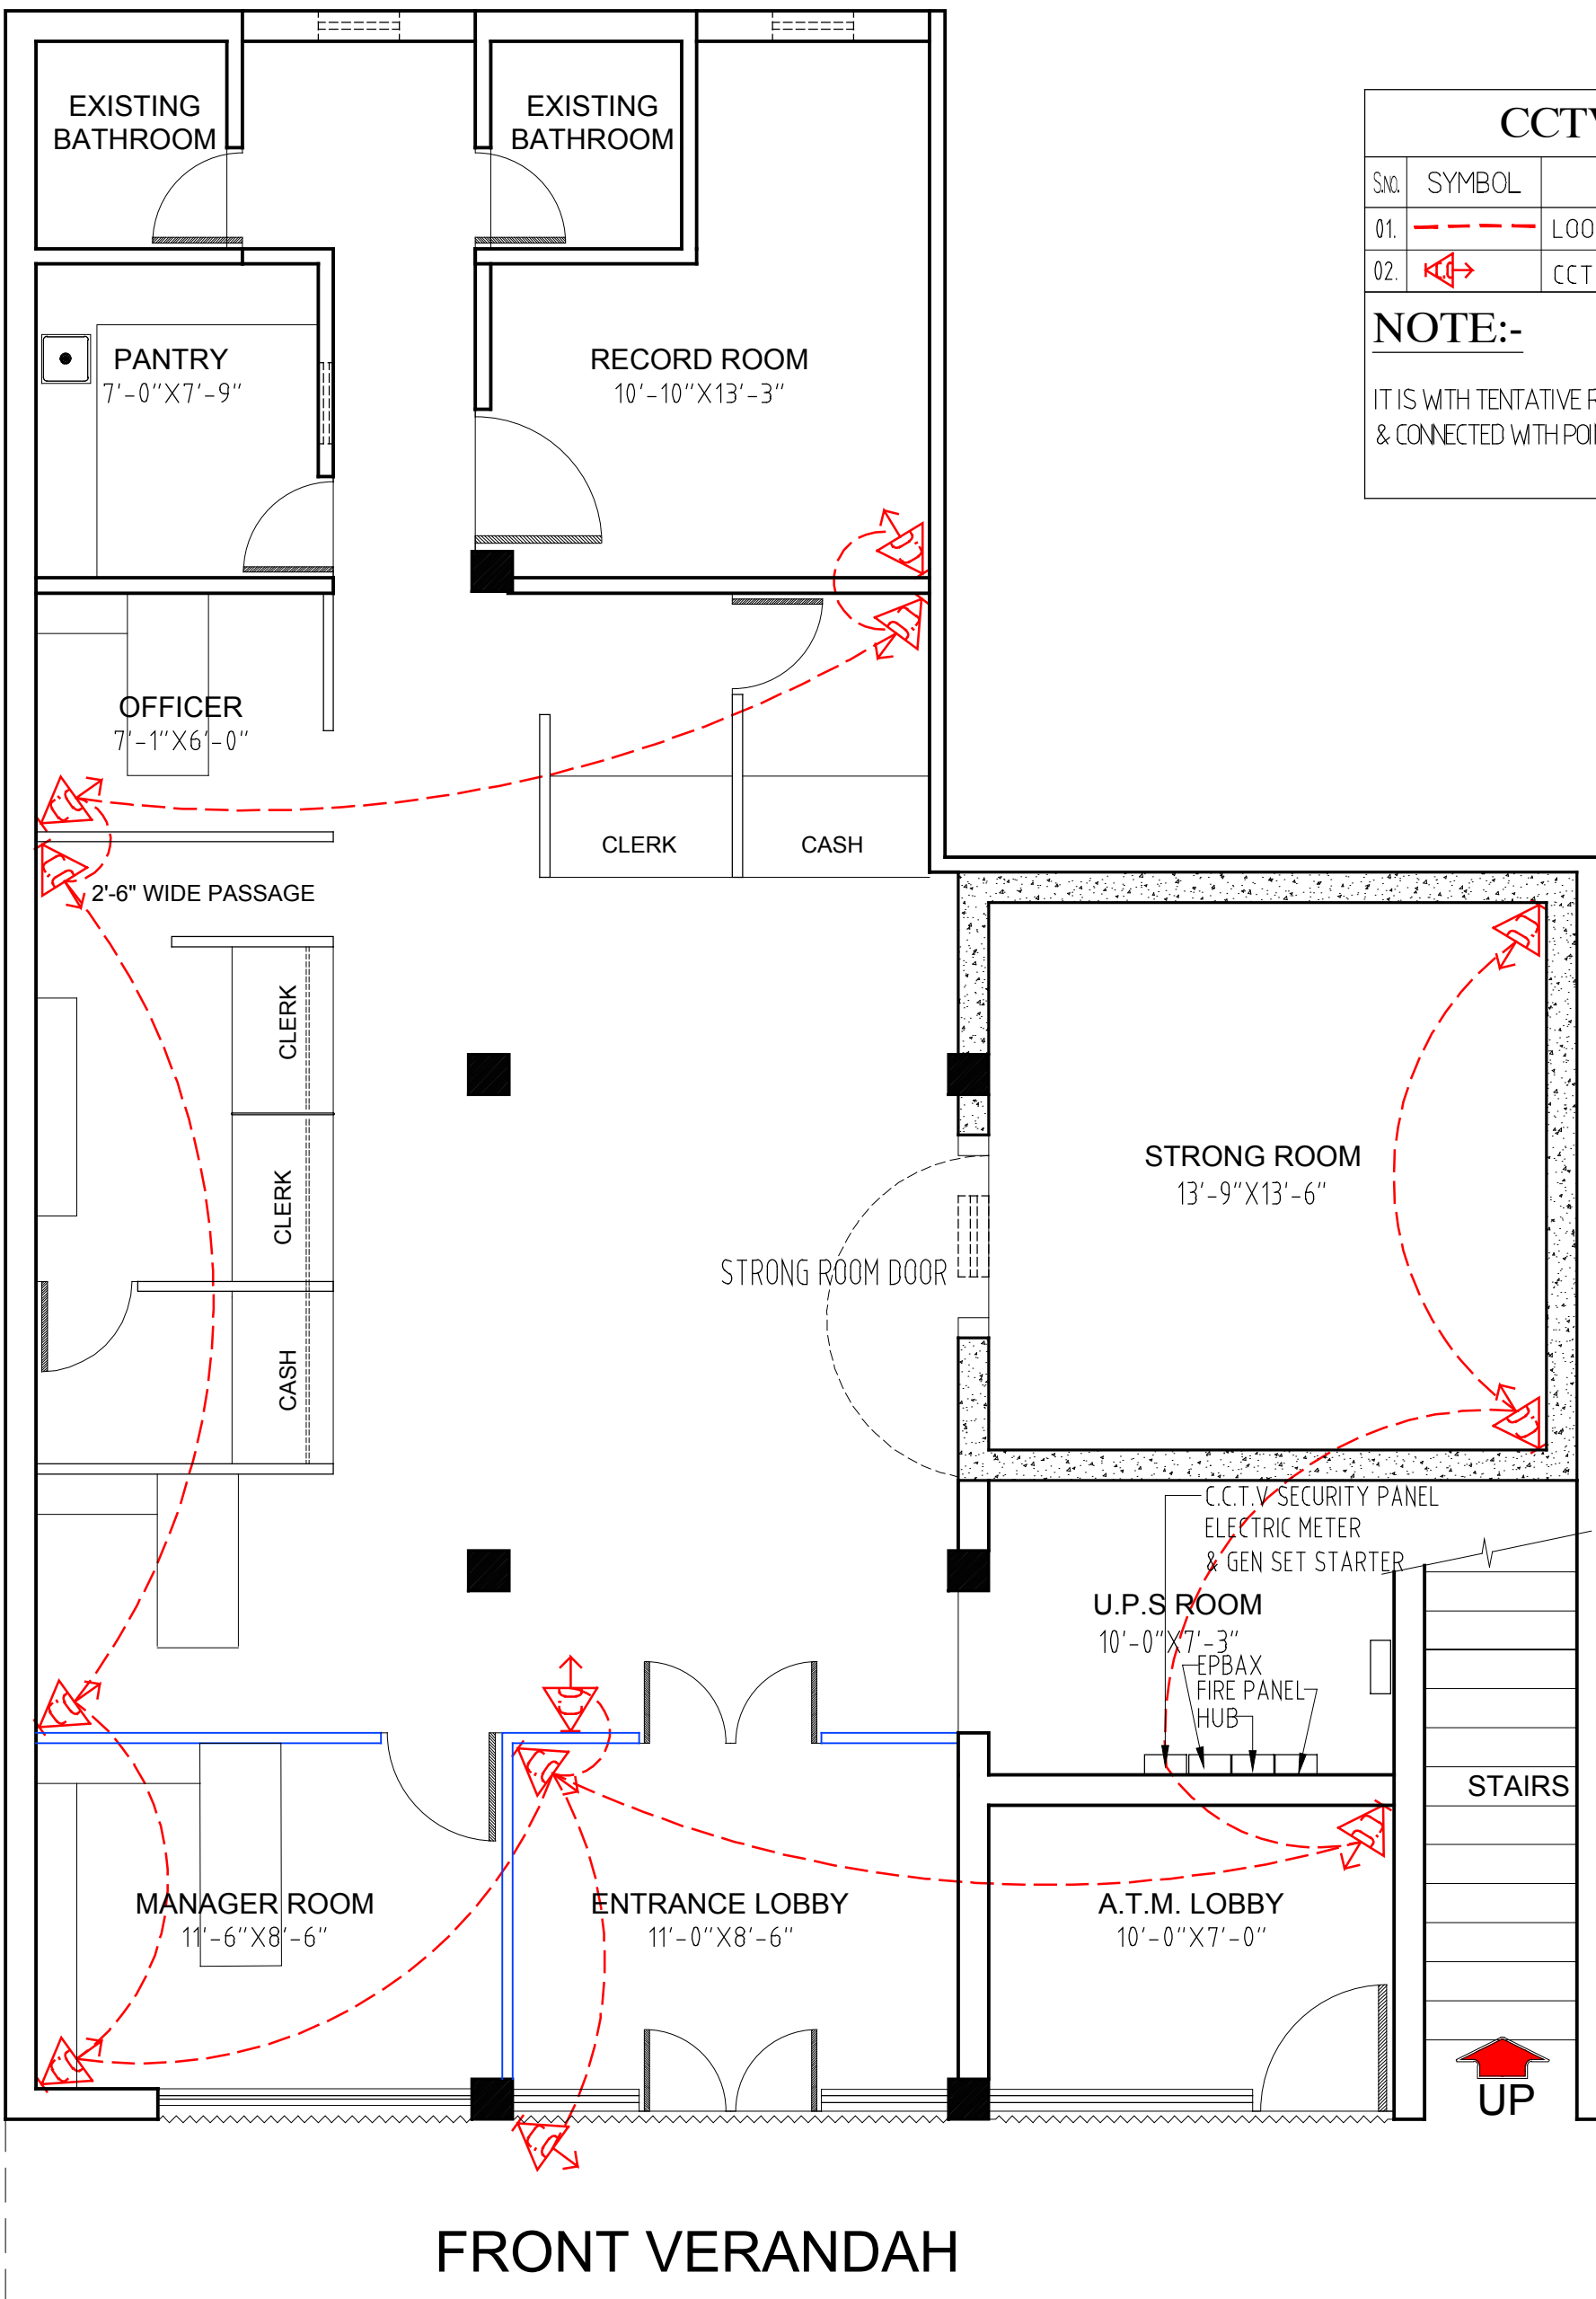

s.no.	date	description	initial
REVISIONS			

The data provided on this drawing is copyright material and the property of the architect. Any copies, changes, reuse or circulation shall have to be authorized with prior approval of the architect in writing.

- NOTES:
- CONTRACTOR TO CHECK & VERIFY ALL DIMENSIONS BEFORE EXECUTION OF THE WORK.
 - FIGURED DIMENSIONS SHALL BE FOLLOWED.
 - ALL DIMENSIONS ARE IN FEET/INCHES, DIMENSIONS ARE TO BE READ AND NOT MEASURED.

SIGNATURE
SIGNATURE
SIGNATURE...

ckd. by Kanav Khosla drn. by SAMAN

ARCHITECTS AND CONSULTANTS.
AVINASH KHOSLA AND ASSO.
568 - A, POLICE HOUSE LINK ROAD,
NEAR FOUNTAIN CHOWK, CIVIL LINES,
LUDHIANA - 8. (PB.)
PH. 2448401 , 2448293 M. 98140-21780
FAX. 0161-2448293 M. 98140-09514
EMAIL. kanavkhosla@consultant.com

AVINASH KHOSLA KANAV KHOSLA
b.arch., f.i.a., m.c.a., f.i.v. b.arch., masters in U.D. (Ext.) U.K.,
f.i.a., m.c.a., s.i.v.

project title :
ELECTRICAL DRAWING

drawing title :
GROUND FLOOR PLAN C.C.T.V & LOOPING LAYOUT

scale :	date :	drg.no.
...	30/08/2024	BK/06/PNB-F/24 EL / 03

FRONT VERANDAH